

ARCHITECTURE INTERIORS PLANNING URBAN DESIGN

500 TREAT AVE. #201 SAN FRANCISCO CALIFORNIA 94110

ARCH@EHDD.COM T 415-285-9193 F 415-285-3866

Consultant

Stamp


Printing Date CONDITIONAL USE PERMIT SUBMITTAL REVISED 12.15.2015

Revision Schedule		
No.	Date	Description

Scale 3/32" = 1'-0" Drawn by JMT EHDD Job Number XXXXX

Sheet Title SITE LIGHTING PLAN

Sheet Number LPL.04

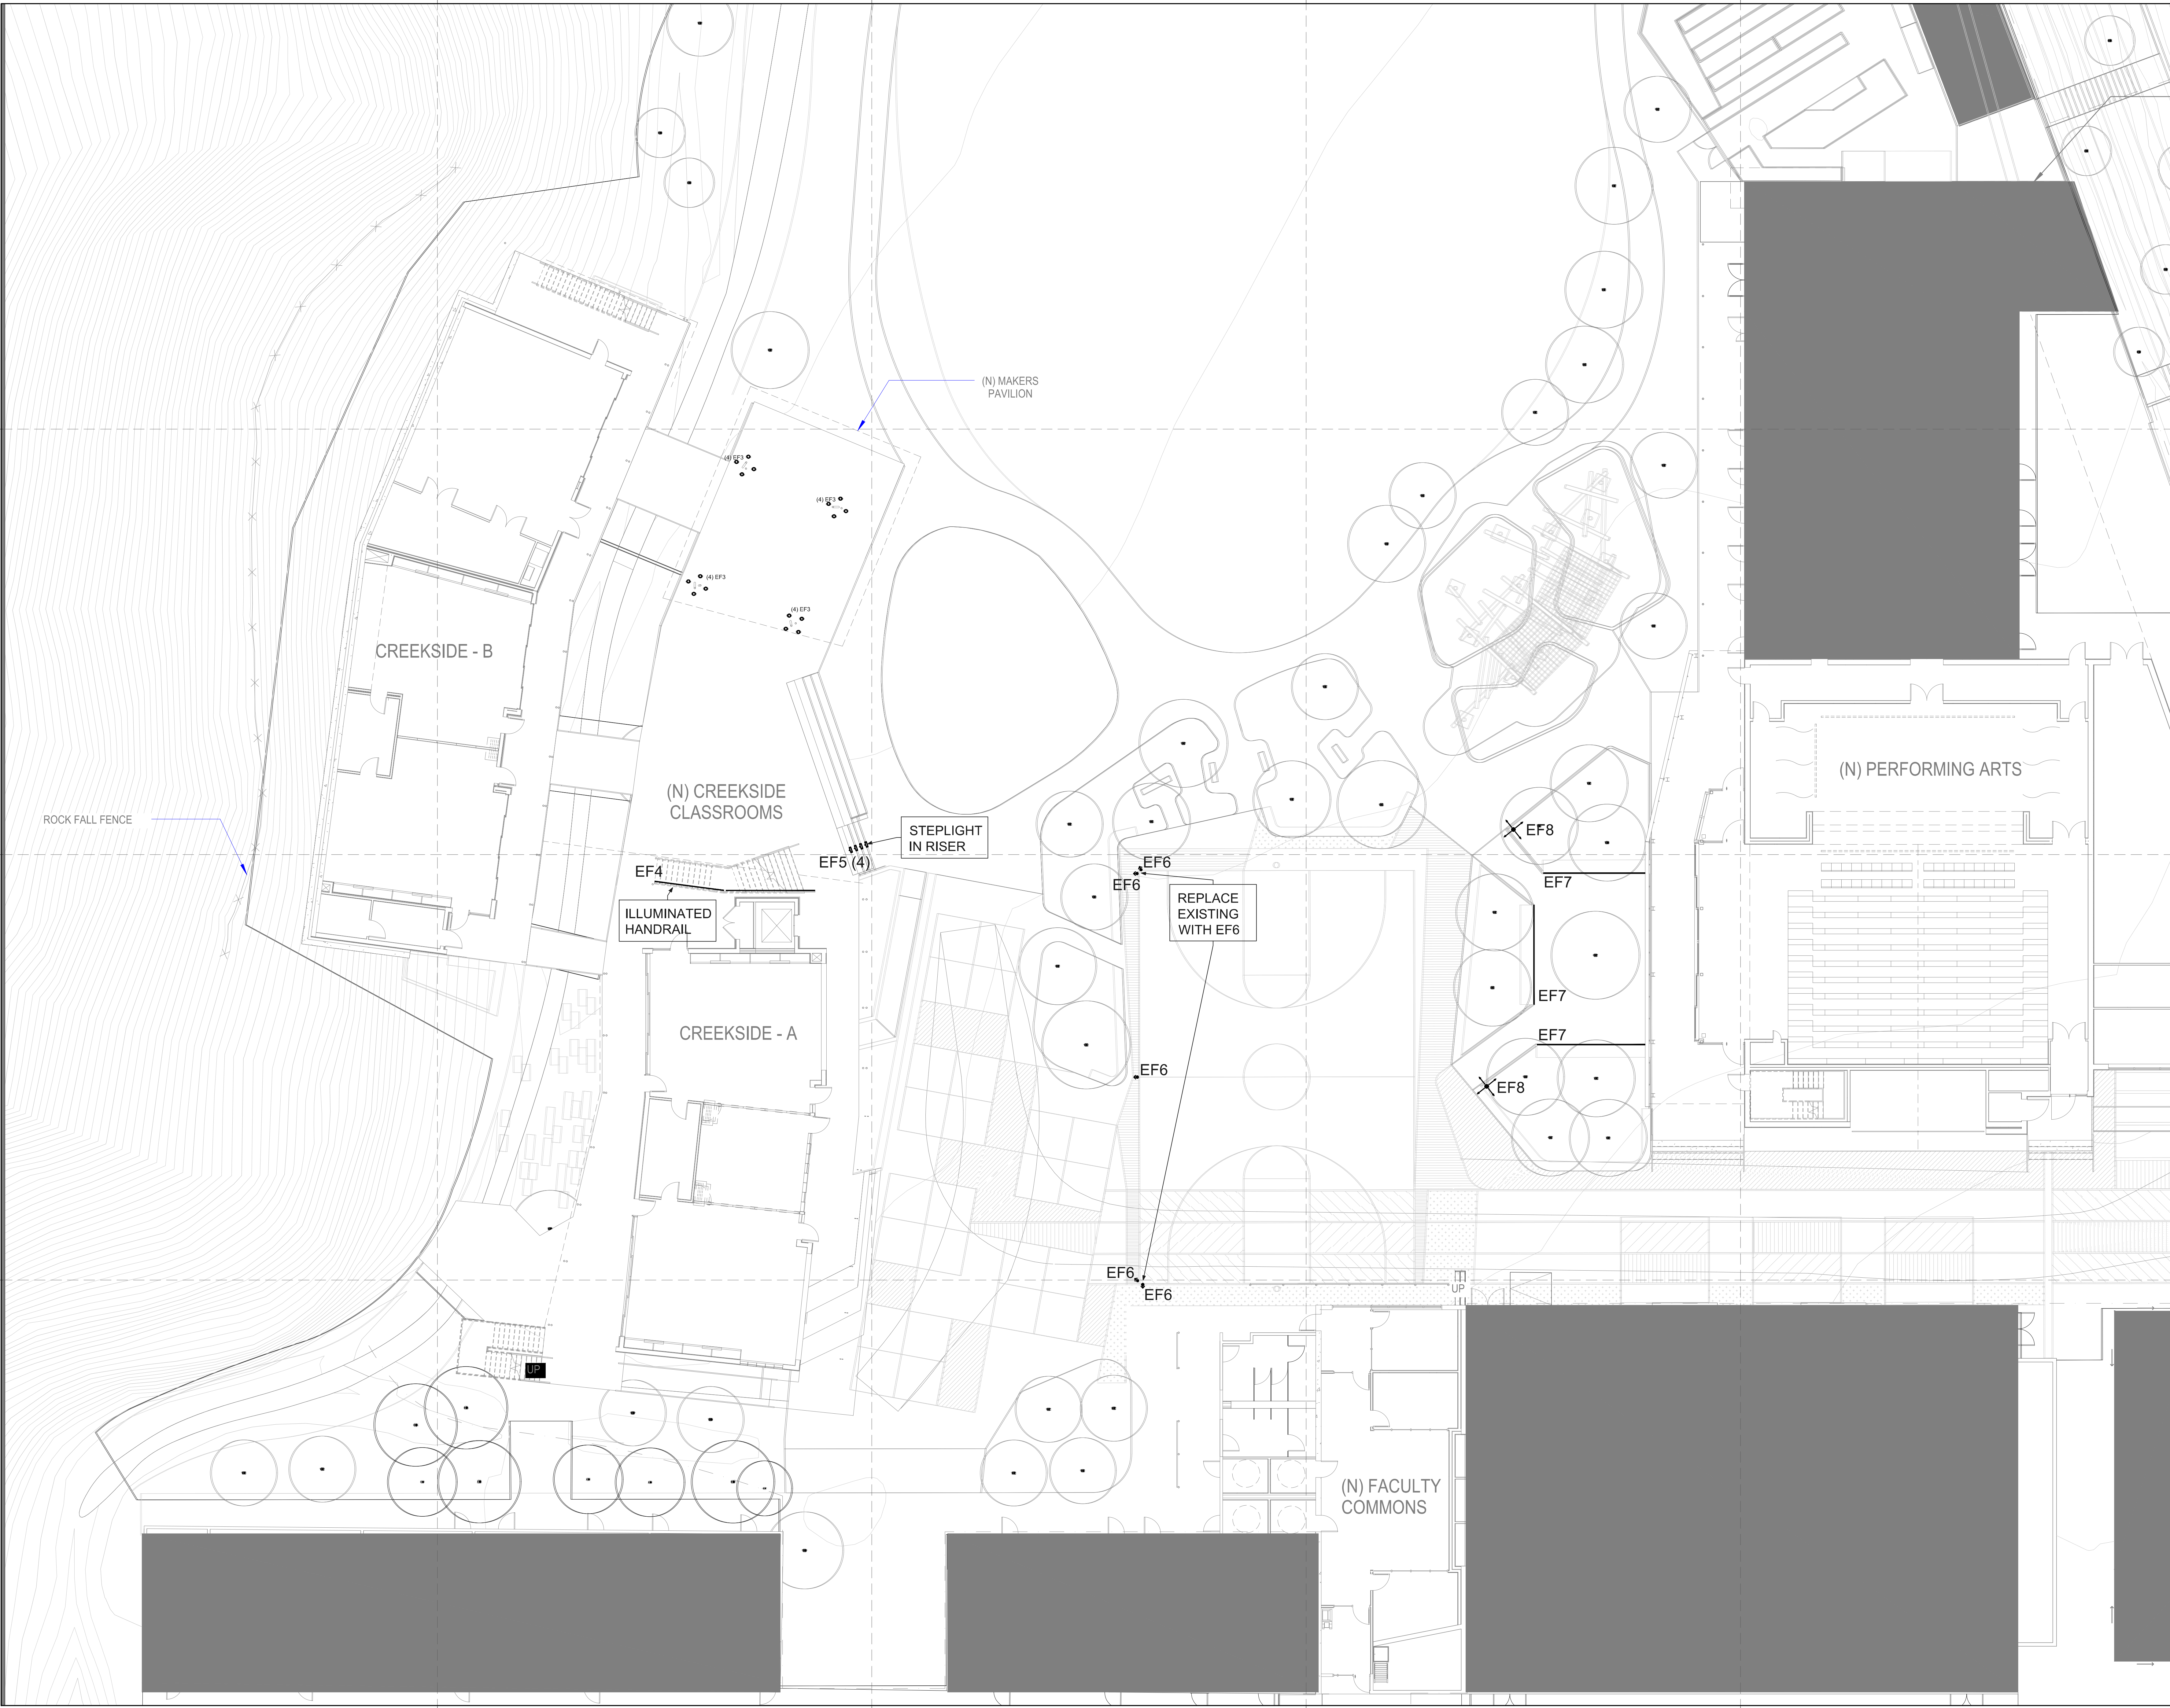

ROCK FALL FENCE

CREEKSIDE - B

(N) CREEKSIDE CLASSROOMS

CREEKSIDE - A

(N) MAKERS PAVILION

(N) PERFORMING ARTS

(N) FACULTY COMMONS

EF4 ILLUMINATED HANDRAIL

EF5 (4) STEPLIGHT IN RISER

REPLACE EXISTING WITH EF6

EF8

EF7

EF7

EF7

EF8

EF6

EF6

EF6

UP